

- Water Bottle Refill Station
- Standard Water Fountain

DWG. NO.:	REVISION DATE:
A-1	07-19-2022
BLDG. CODE:	SCALE:
GC	NTS
	DESIGN BY:
	PLL
	CHECKED BY:
	MJG


RECORD FLOOR PLAN
GUERRIERI STUDENT UNION

FIRST FLOOR PLAN

SALISBURY UNIVERSITY
FACILITIES PLANNING & CAPITAL PROJECTS
ARCHITECTURAL AND ENGINEERING SERVICES
1101 CAMDEN AVENUE
SALISBURY, MARYLAND 21801
410-543-6215

● Water Bottle Refill Station

● Standard Water Fountain

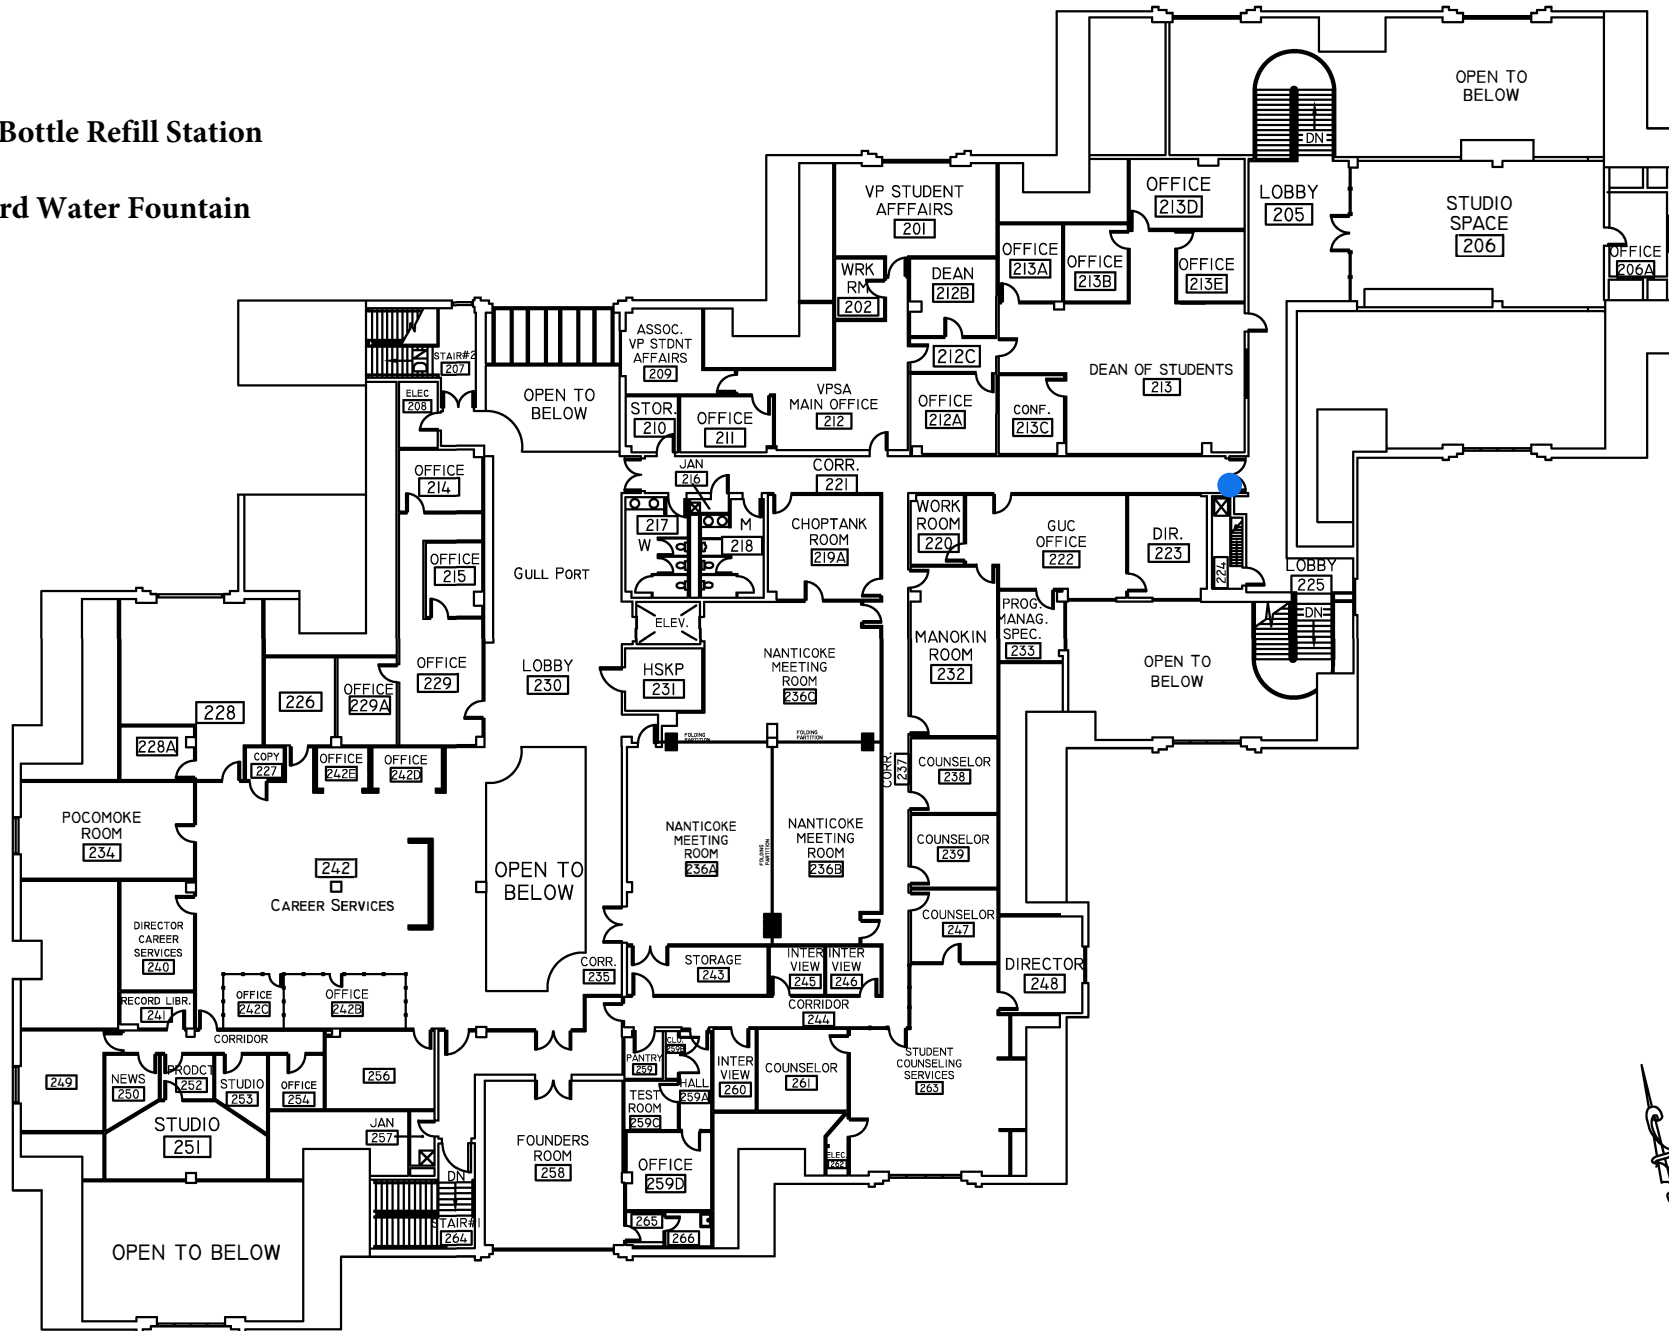

DWG. NO.:	REVISION DATE:
A-2	07-19-2022
BLDG. CODE:	SCALE:
GC	NTS
	DESIGN BY:
	PLL
	CHECKED BY:
	MJG

**RECORD FLOOR PLAN
GUERRIERI STUDENT UNION**

SECOND FLOOR PLAN

SALISBURY UNIVERSITY
FACILITIES PLANNING & CAPITAL PROJECTS
ARCHITECTURAL AND ENGINEERING SERVICES
1101 CAMDEN AVENUE
SALISBURY, MARYLAND 21801
410 - 543 - 6215