


● Water Bottle Refill Station

● Standard Water Fountain

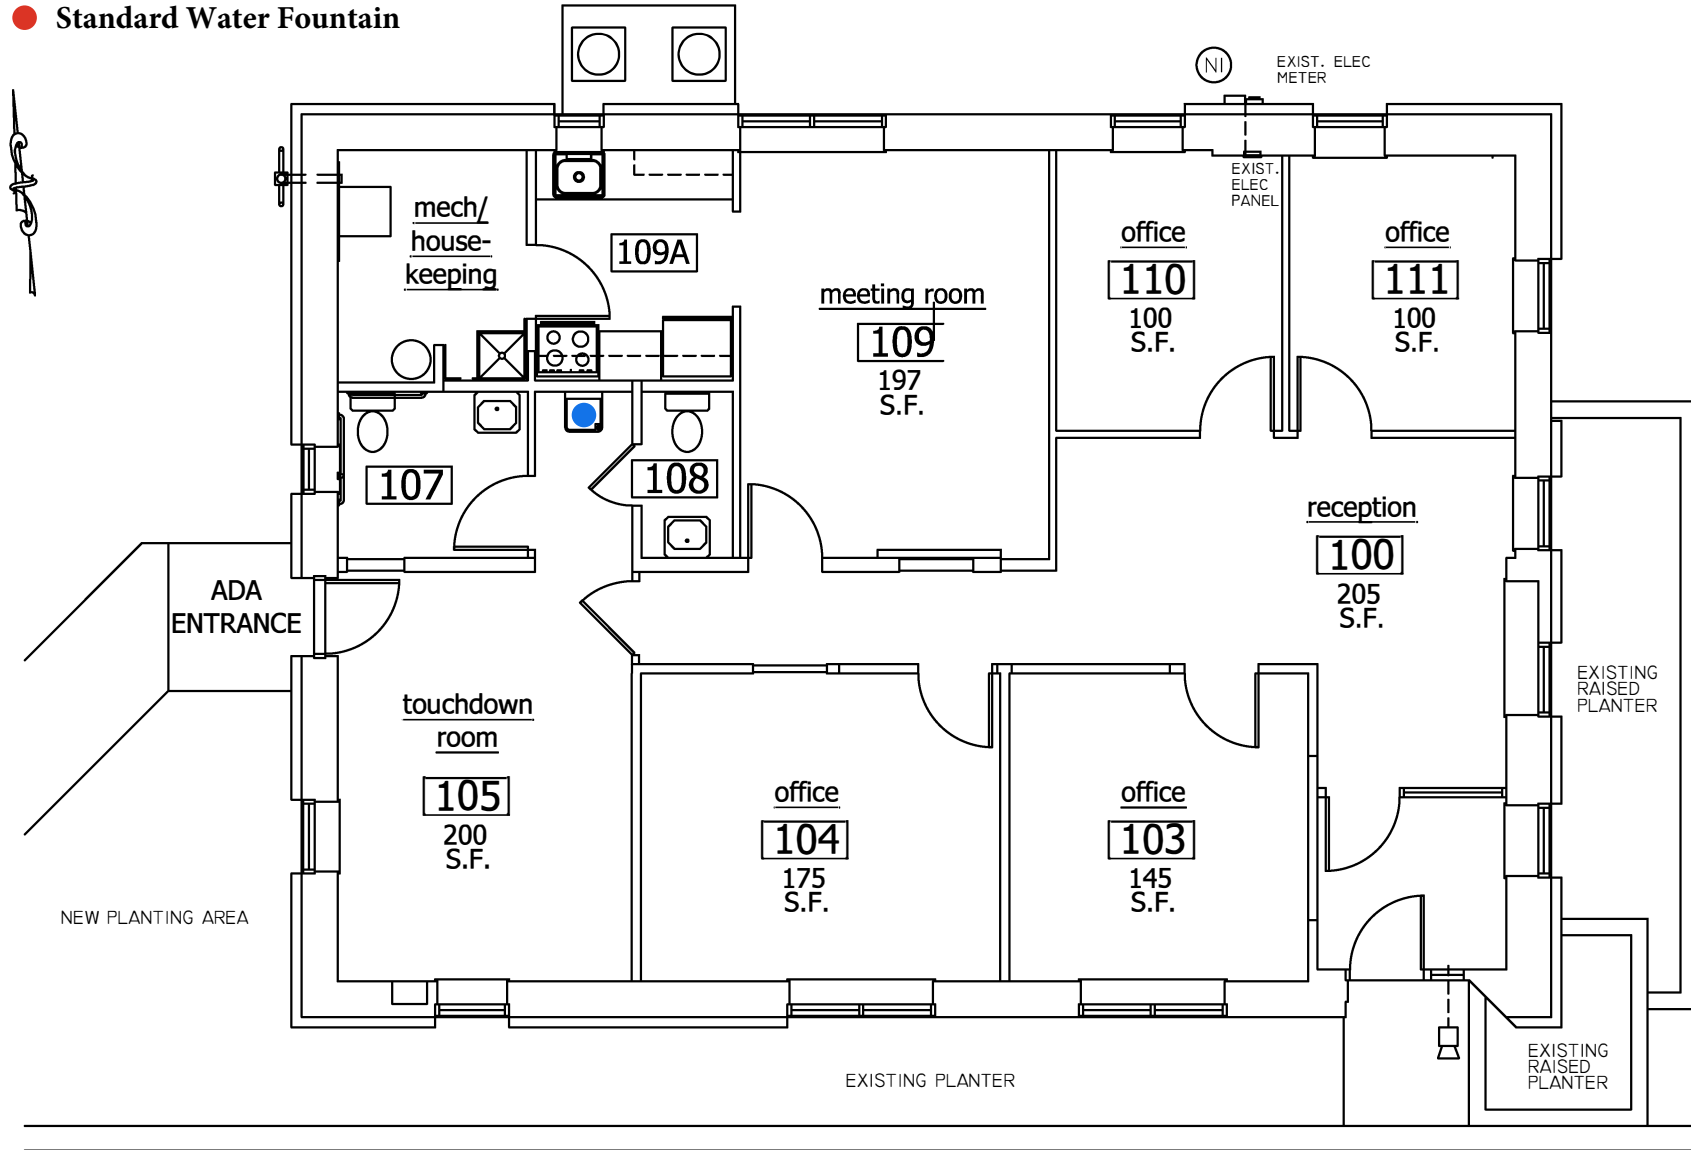

DWG. NO.:	REVISION DATE:
A-1	07-17-2019
	SCALE: 1/8" = 1'
BLDG. CODE:	DESIGN BY: PLA
D1	CHECKED BY: JCD

RECORD FLOOR PLAN
DIVISION STREET BUILDING 1

FIRST FLOOR PLAN

SALISBURY UNIVERSITY
FACILITIES PLANNING & CAPITAL PROJECTS
ARCHITECTURAL AND ENGINEERING SERVICES
1101 CAMDEN AVENUE
SALISBURY, MARYLAND 21801
410 - 543 - 6215