


LOCATION PLAN
MAGGS CENTER
NO SCALE

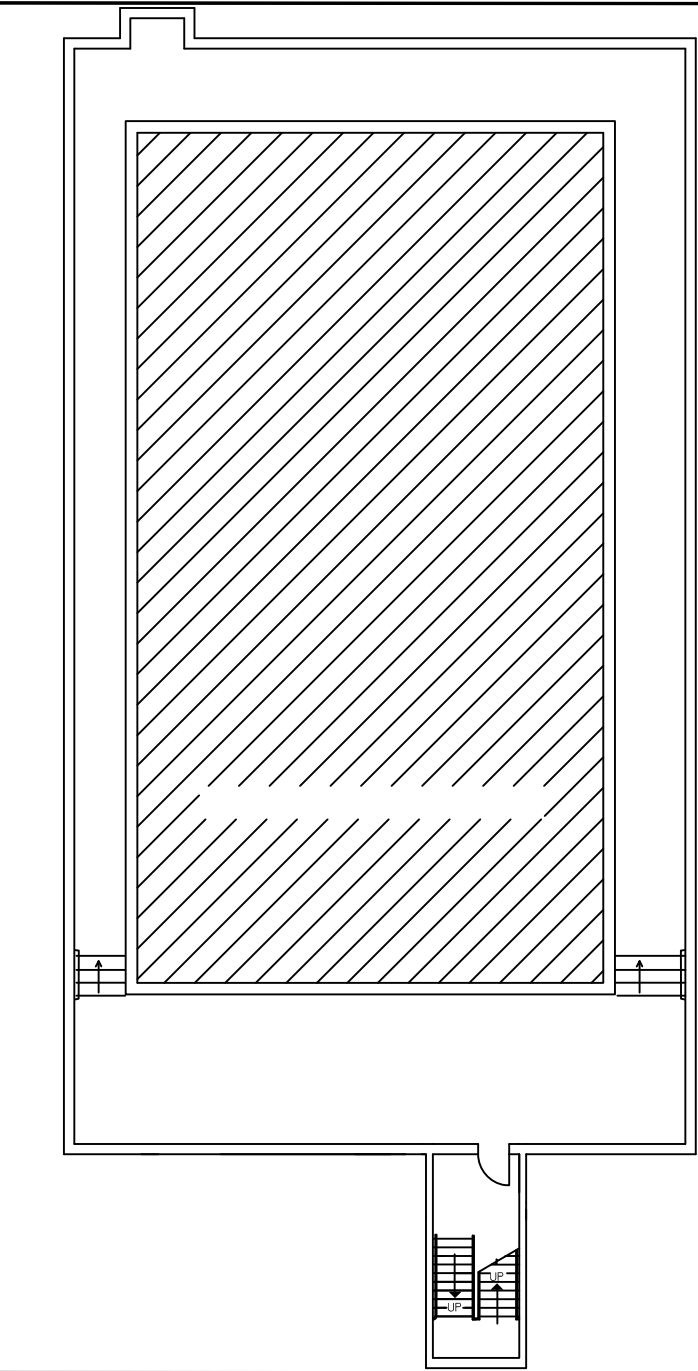

DWG. NO.:	REVISION DATE:
A-0	01-03-2018
BLDG. CODE:	SCALE:
MC	NTS
	DESIGN BY:
	PLA
	CHECKED BY:
	JCD


RECORD FLOOR PLAN
MAGGS CENTER

BASEMENT FLOOR PLAN

SALISBURY UNIVERSITY
FACILITIES PLANNING & CAPITAL PROJECTS
ARCHITECTURAL AND ENGINEERING SERVICES
1101 CAMDEN AVENUE
SALISBURY, MARYLAND 21801
410 - 543 - 6215

● Water Bottle Refill Station

● Standard Water Fountain

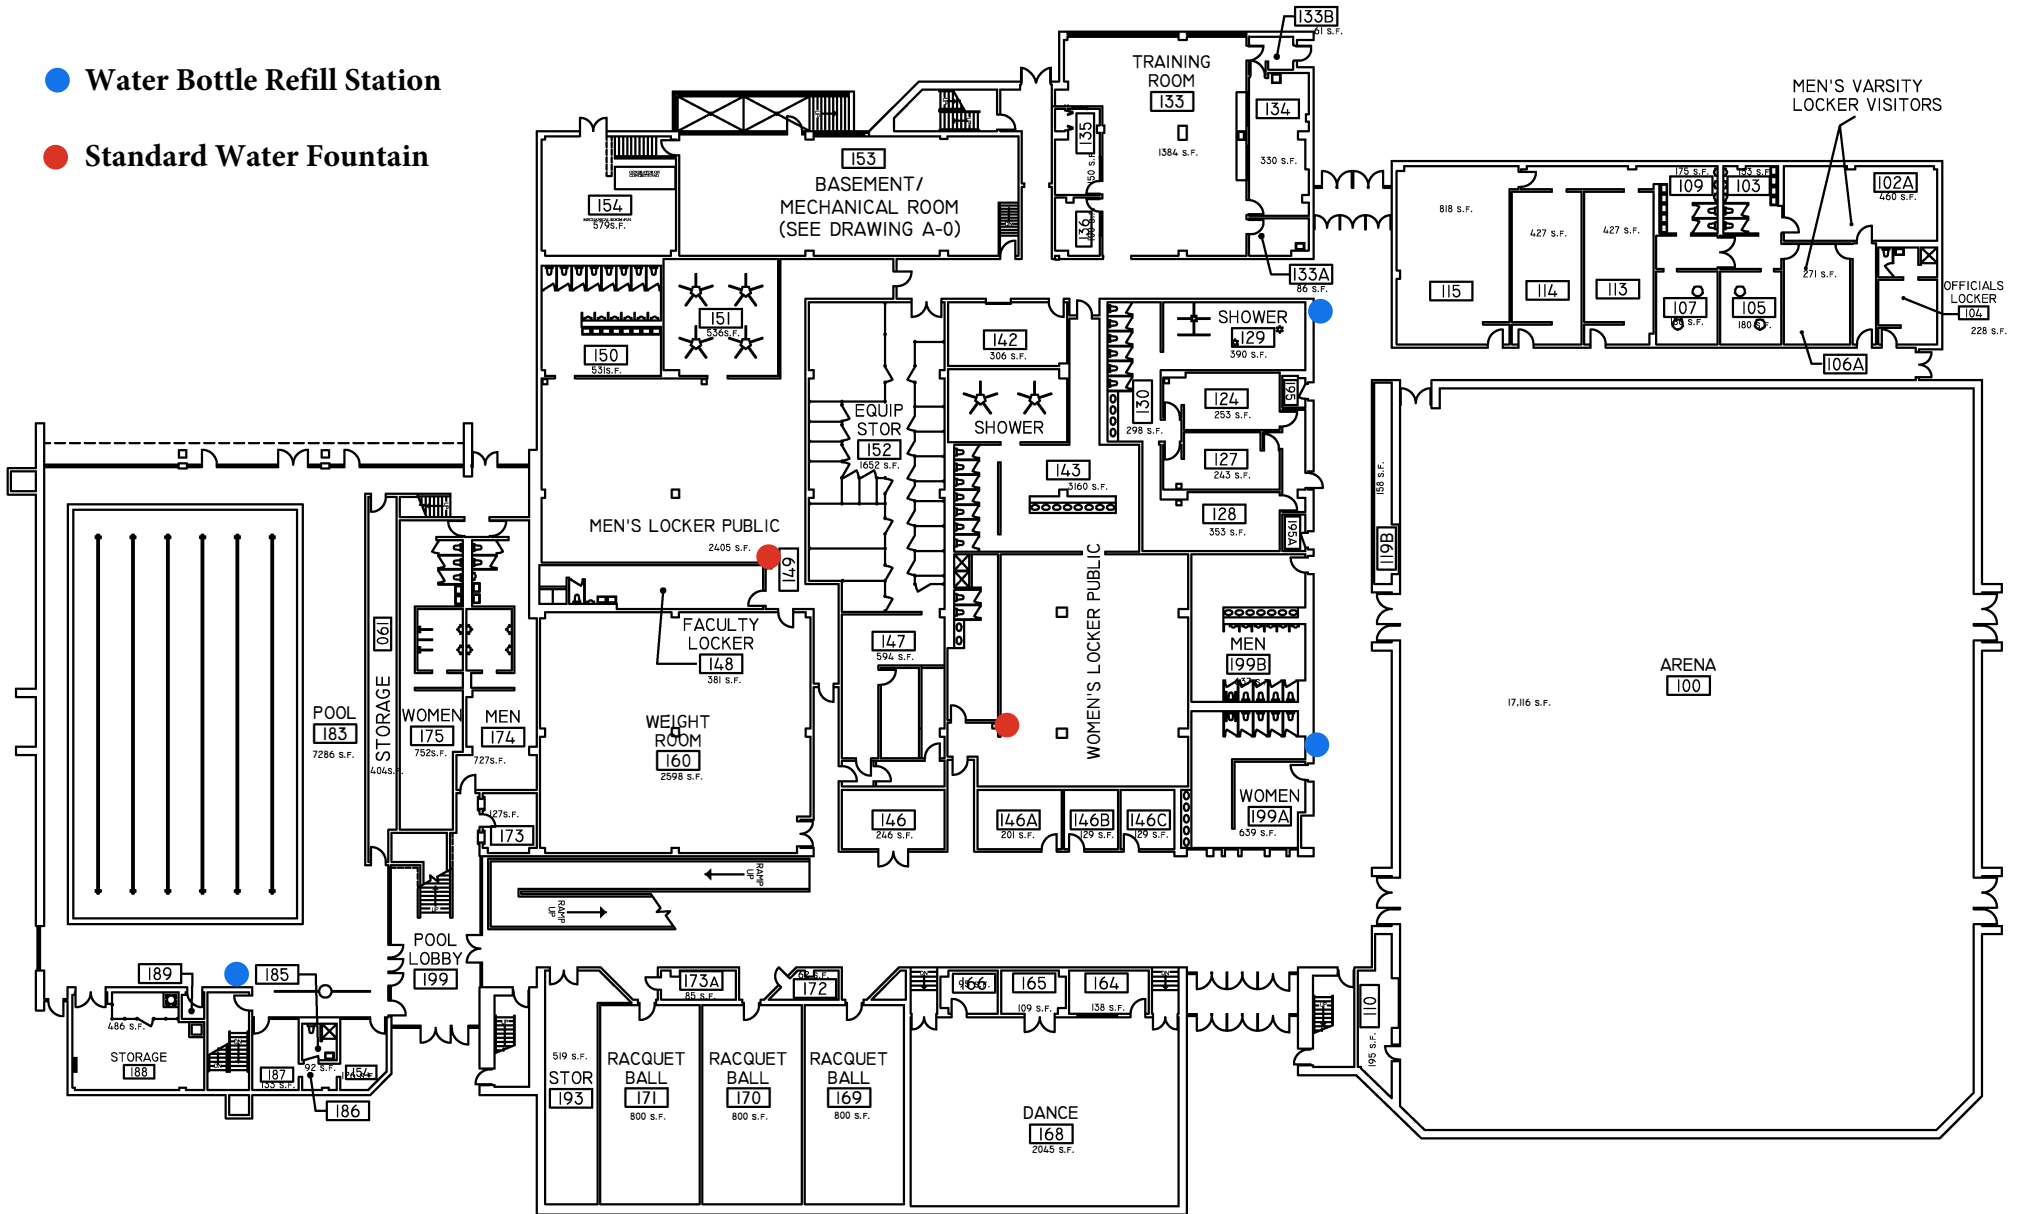


DWG. NO.:	REVISION DATE:
A-1	01-03-2018
BLDG. CODE:	SCALE:
MC	NTS
	DESIGN BY:
	PLA
	CHECKED BY:
	JCD

RECORD FLOOR PLAN
MAGGS CENTER

FIRST FLOOR PLAN

SALISBURY UNIVERSITY
FACILITIES PLANNING & CAPITAL PROJECTS
ARCHITECTURAL AND ENGINEERING SERVICES
1101 CAMDEN AVENUE
SALISBURY, MARYLAND 21801
410 - 543 - 6215

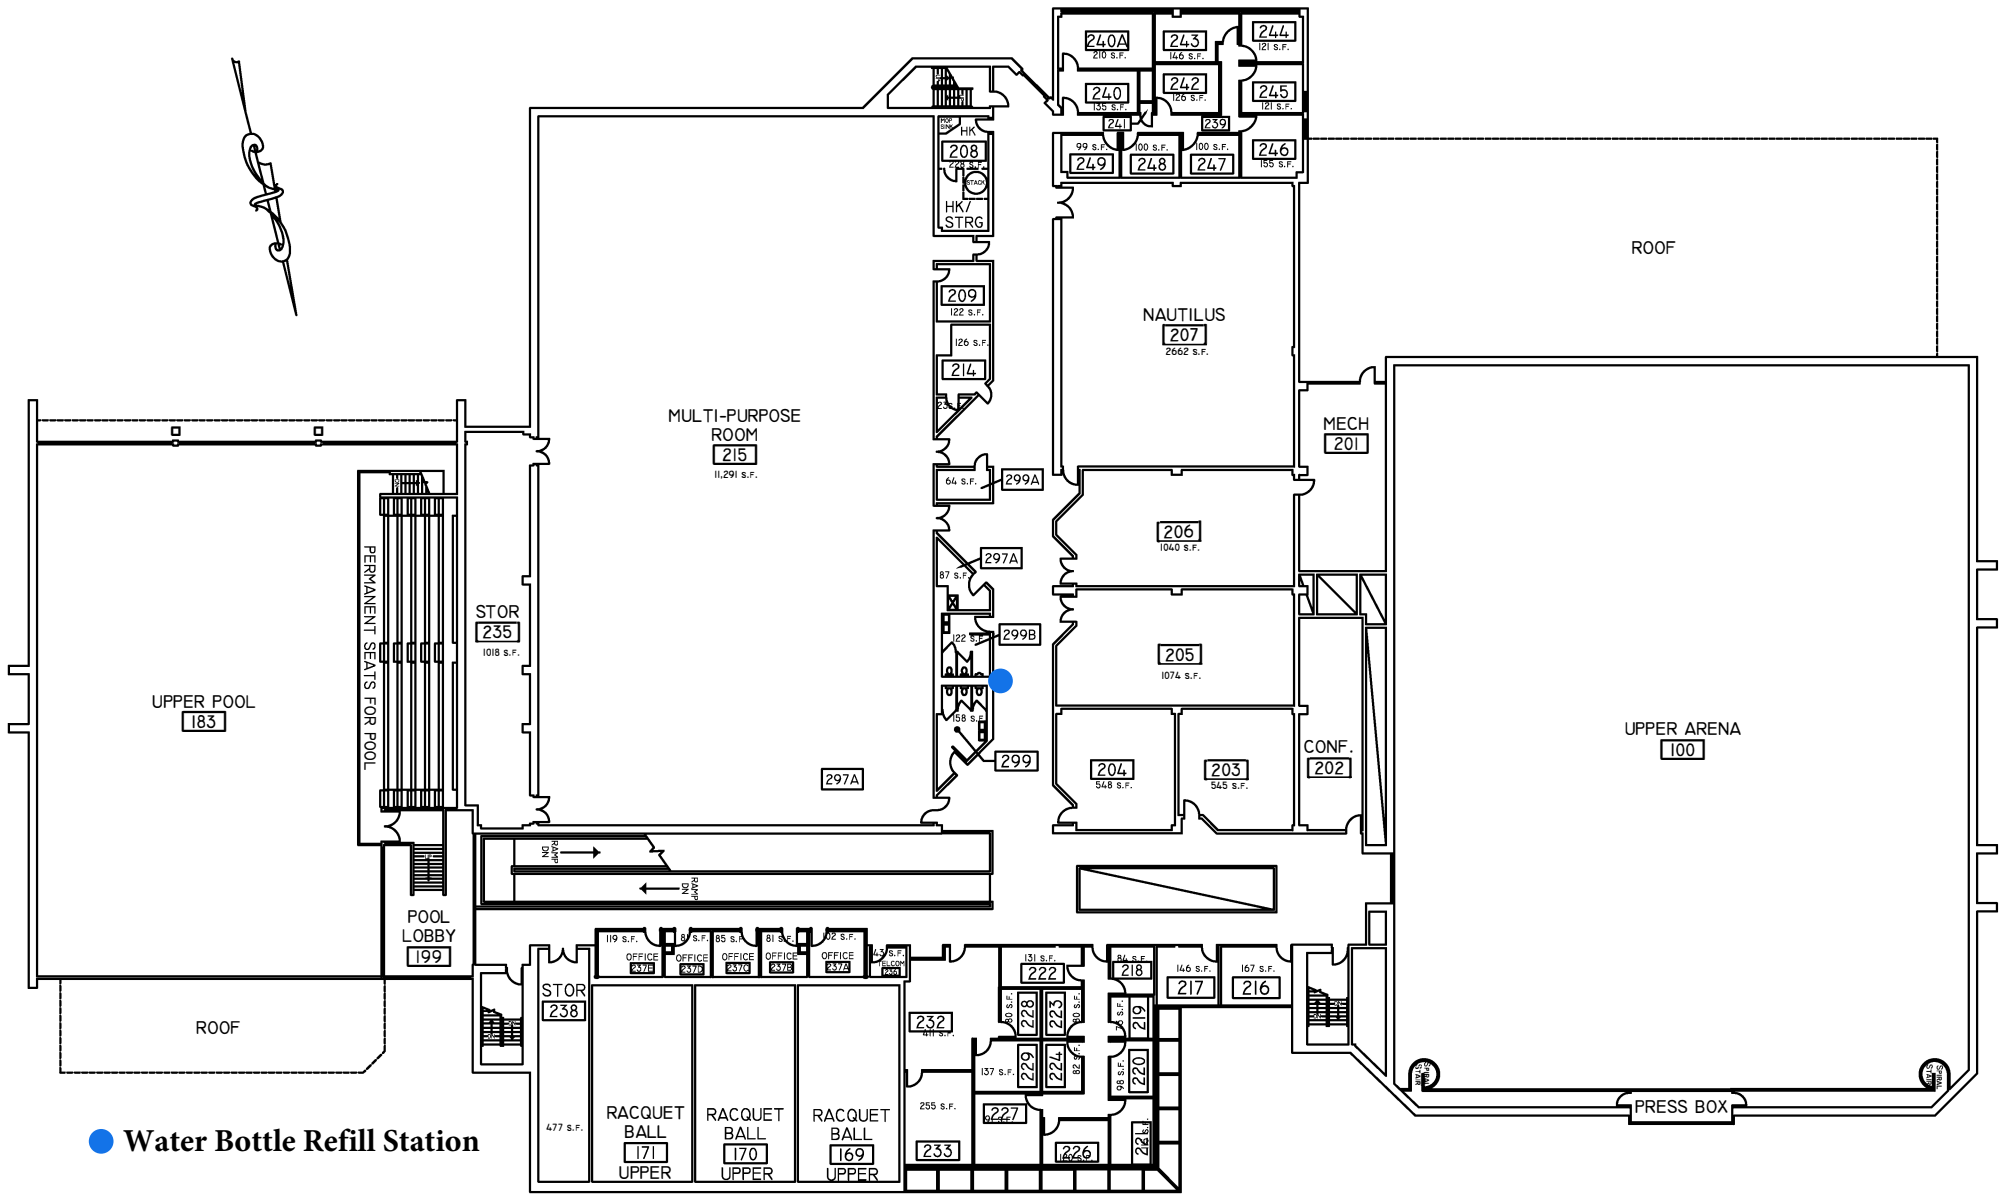

- Water Bottle Refill Station
- Standard Water Fountain

DWG. NO.:	REVISION DATE:
A-2	01-03-2018
	SCALE: NTS
	DESIGN BY: PLA
BLDG. CODE:	CHECKED BY: JCD
MC	

RECORD FLOOR PLAN
MAGGS CENTER

SECOND FLOOR PLAN

SALISBURY UNIVERSITY
 FACILITIES PLANNING & CAPITAL PROJECTS
 ARCHITECTURAL AND ENGINEERING SERVICES
 1101 CAMDEN AVENUE
 SALISBURY, MARYLAND 21801
 410 - 543 - 6215