


- Water Bottle Refill Station
- Standard Water Fountain

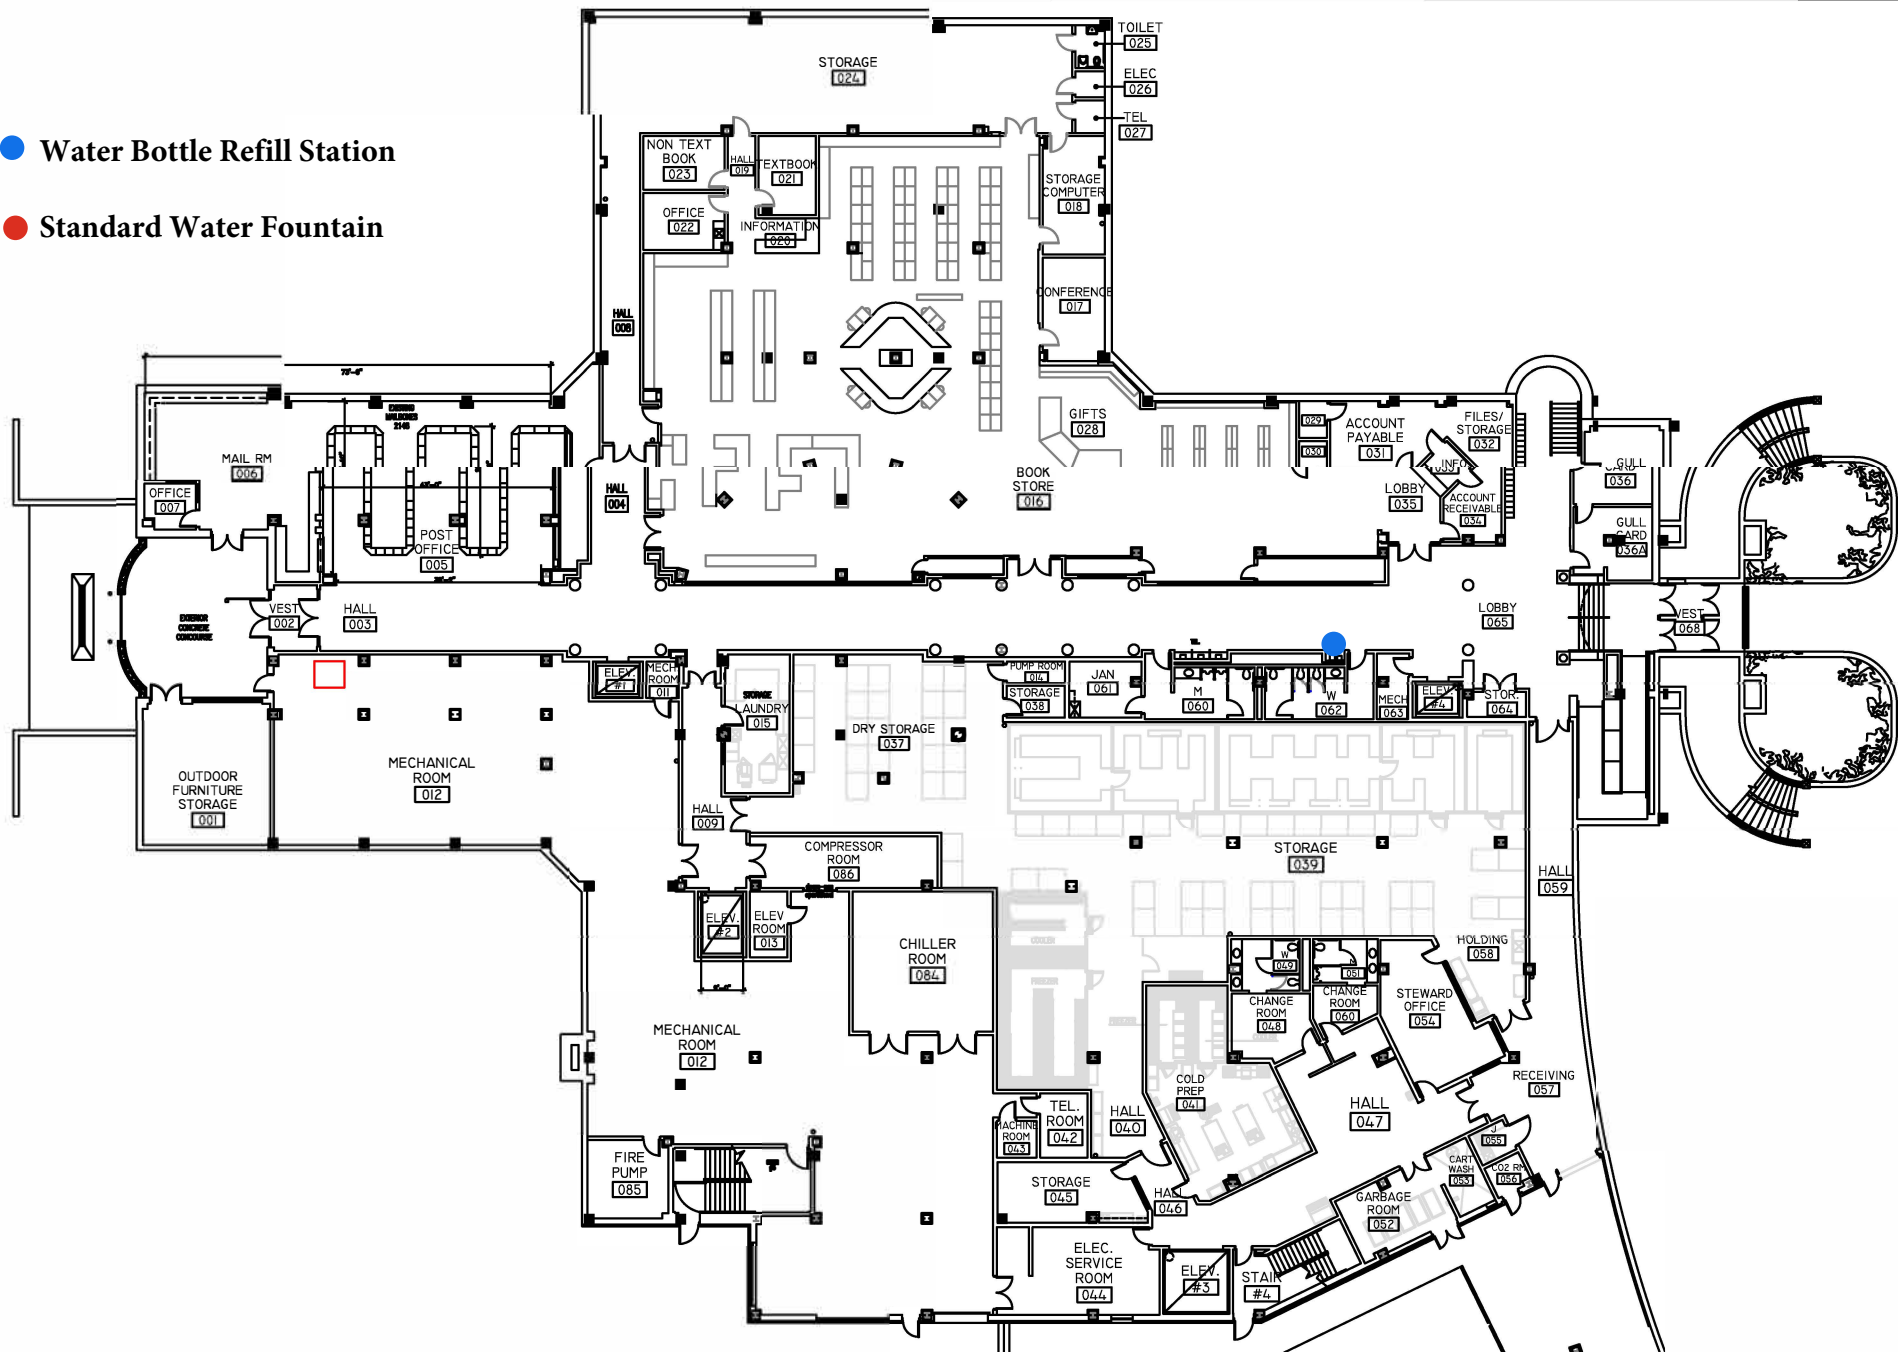


DWG. NO.:	REVISION DATE:
A-0	12-12-2018
BLDG. CODE:	SCALE:
CB	NTS
	DESIGN BY:
	PLA
	CHECKED BY:
	JCD

**RECORD FLOOR PLAN
COMMONS BUILDING**

BASEMENT FLOOR PLAN

SALISBURY UNIVERSITY
 FACILITIES PLANNING & CAPITAL PROJECTS
 ARCHITECTURAL AND ENGINEERING SERVICES
 1101 CAMDEN AVENUE
 SALISBURY, MARYLAND 21801
 410 - 543 - 6215

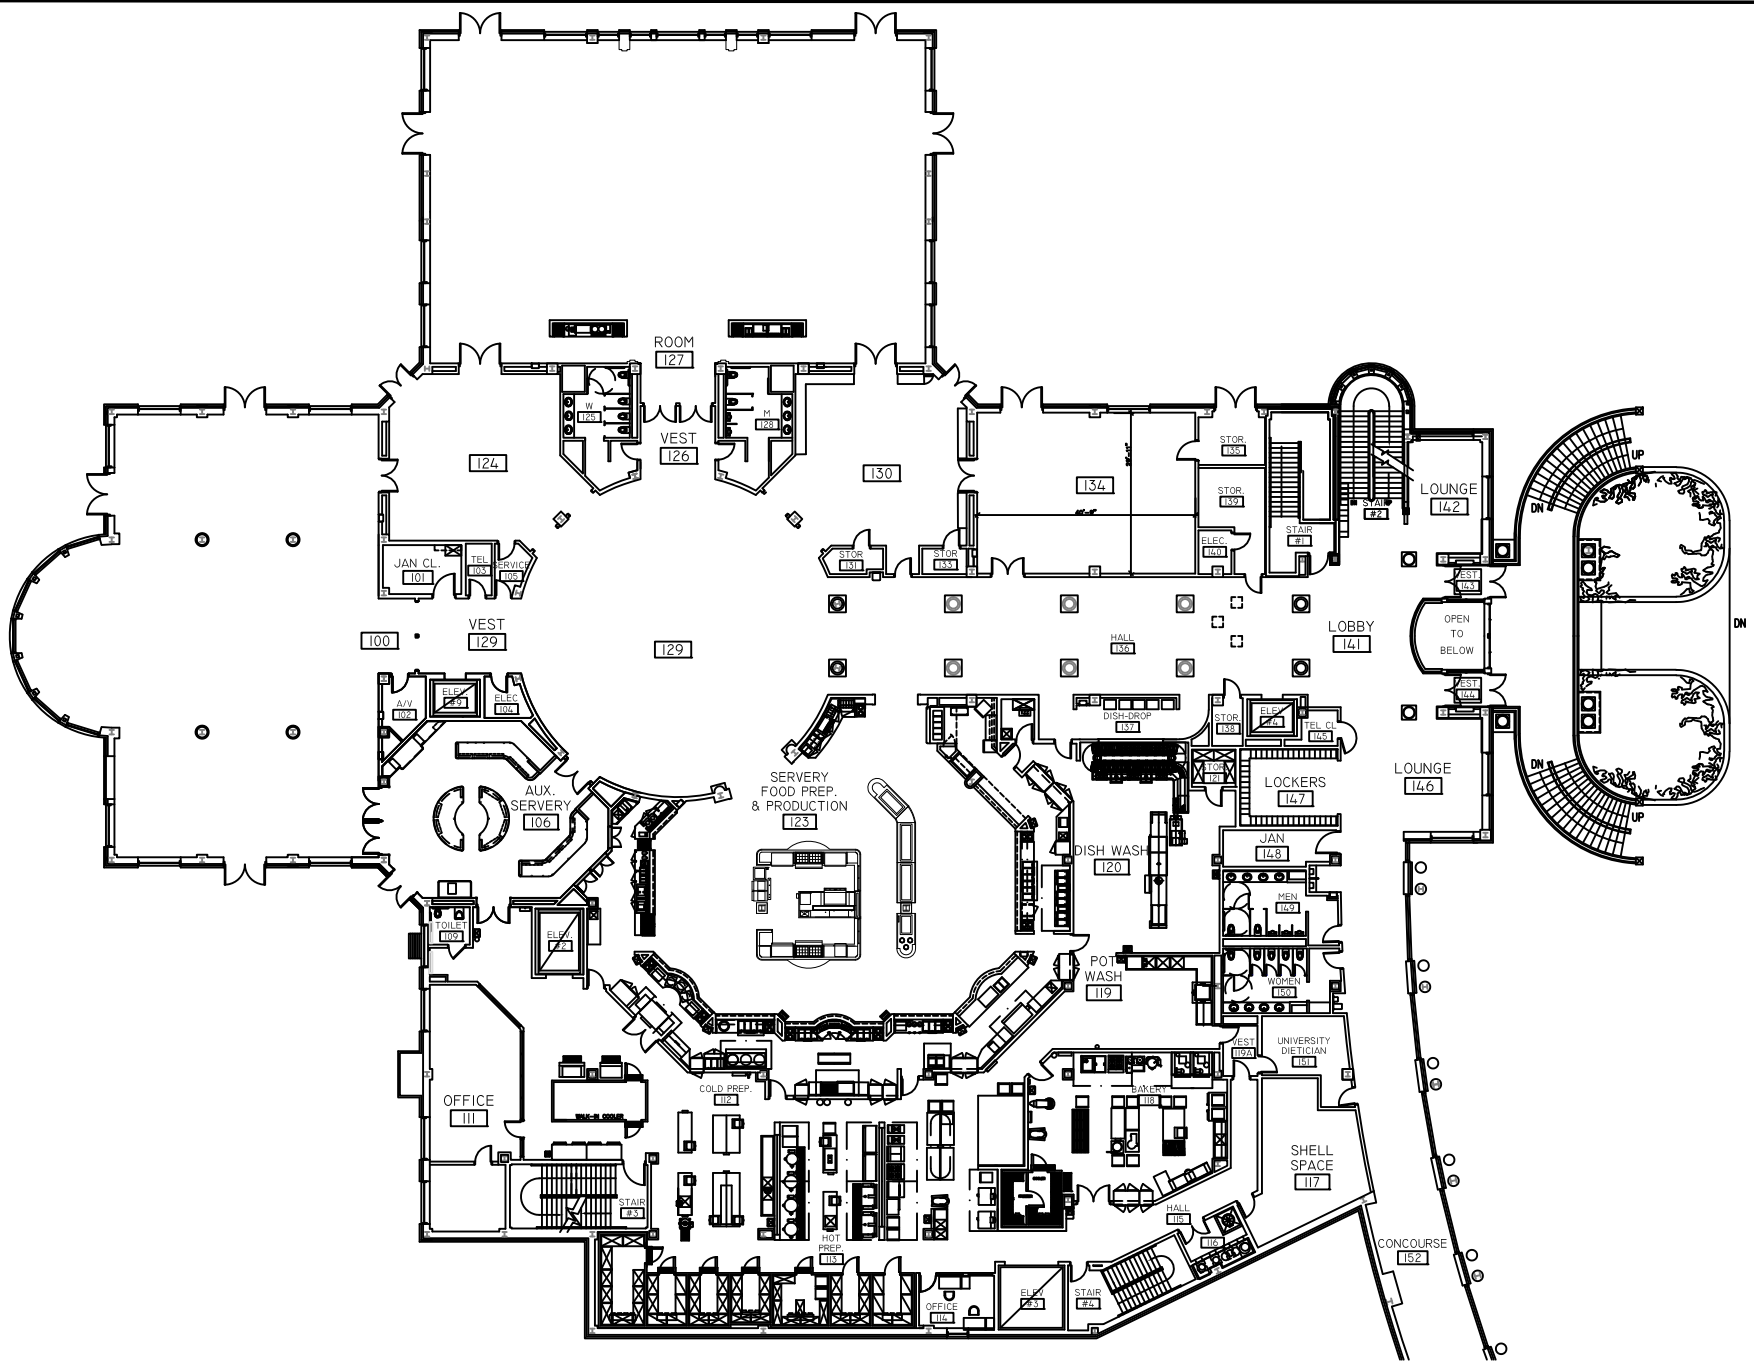

DWG. NO.:	REVISION DATE:
A-I	12-12-2018
BLDG. CODE:	SCALE:
CB	NTS
	DESIGN BY:
	PLA
	CHECKED BY:
	JCD


RECORD FLOOR PLAN
COMMONS BUILDING

FIRST FLOOR PLAN

SALISBURY UNIVERSITY
 FACILITIES PLANNING & CAPITAL PROJECTS
 ARCHITECTURAL AND ENGINEERING SERVICES
 1101 CAMDEN AVENUE
 SALISBURY, MARYLAND 21801
 410 - 543 - 6215

● Water Bottle Refill Station

● Standard Water Fountain

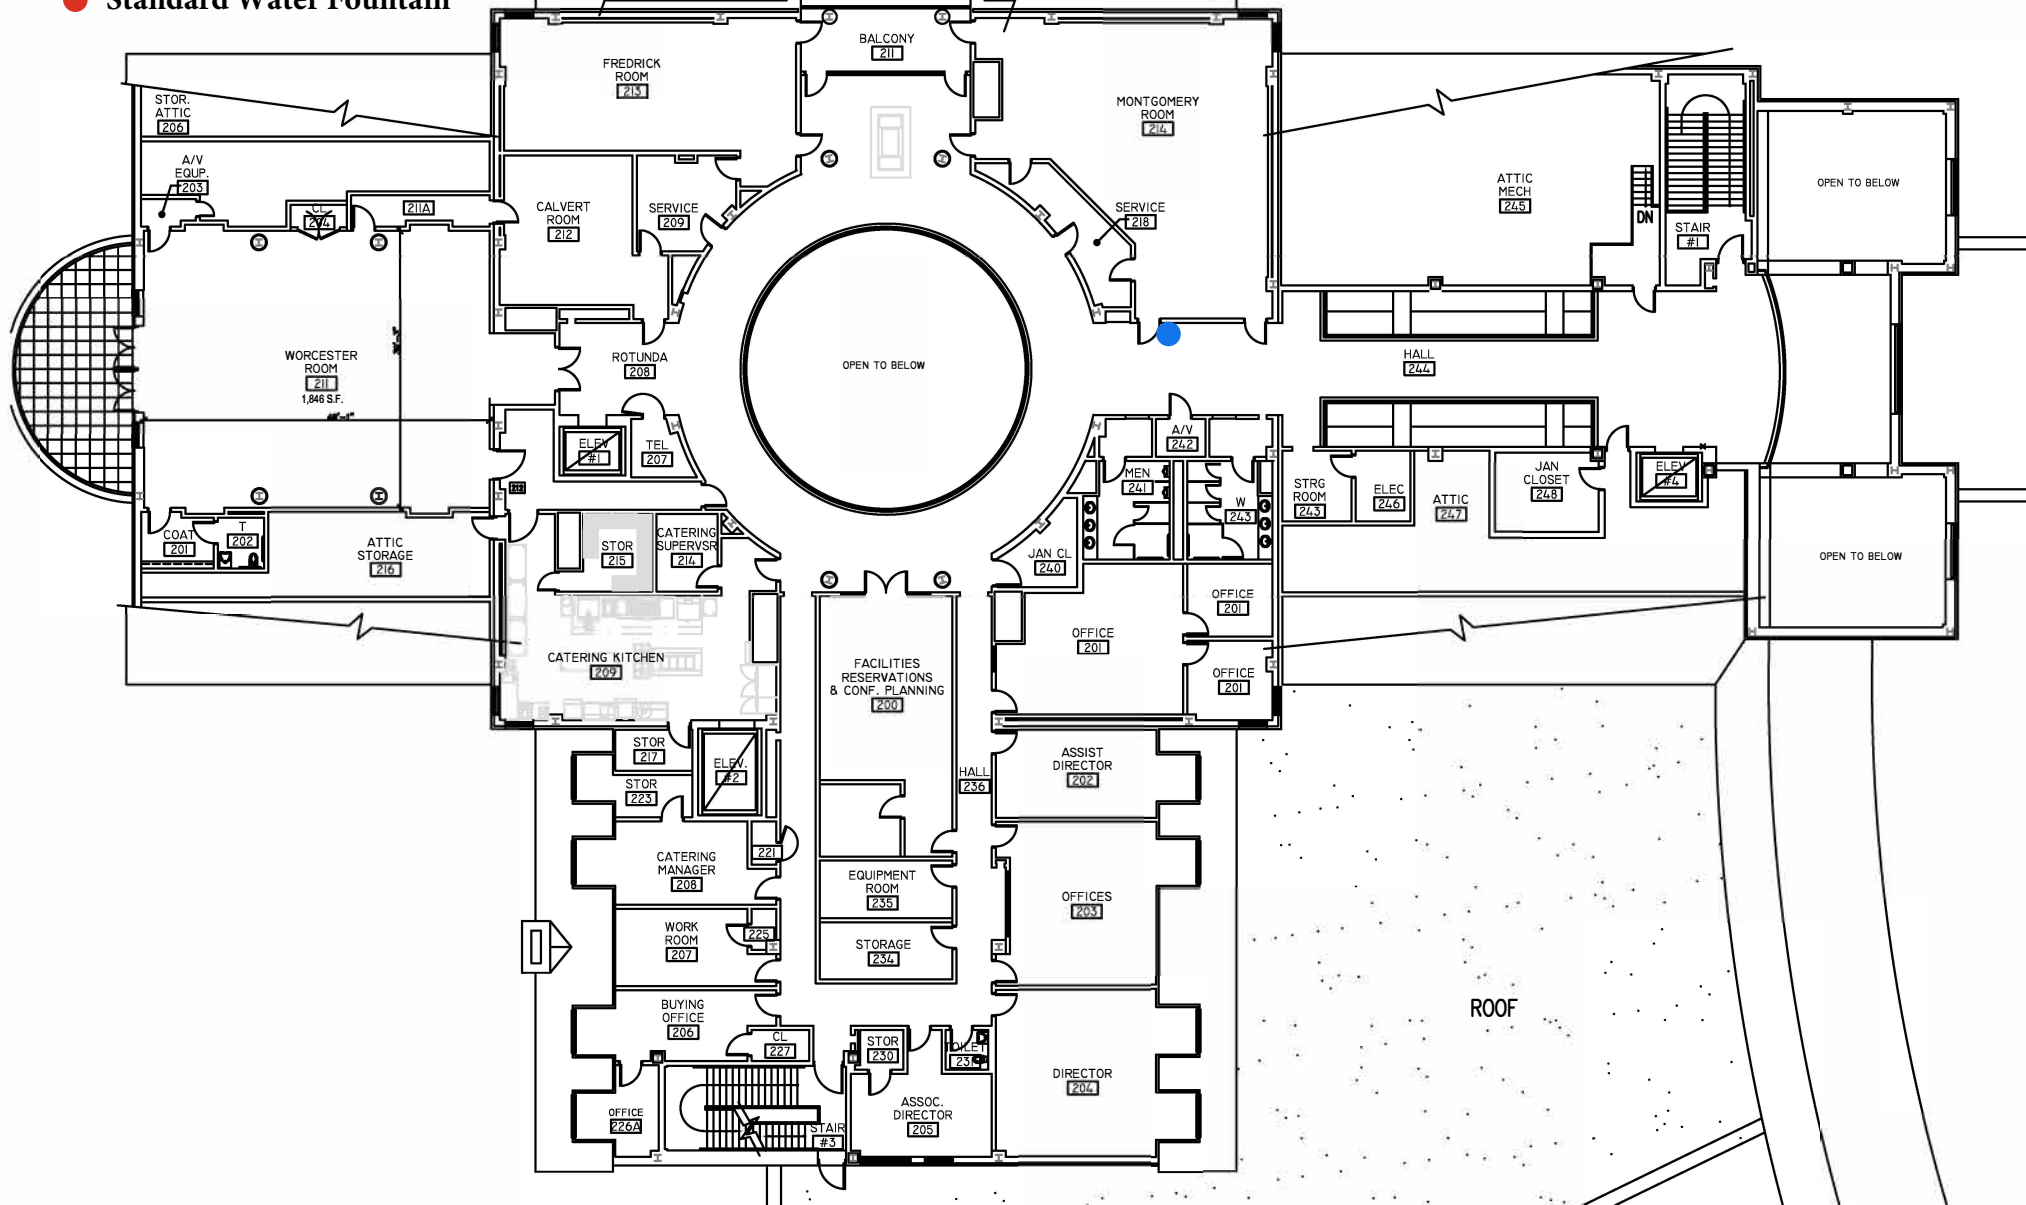

DWG. NO.:	REVISION DATE:
A-2	03-22-2014
BLDG. CODE:	SCALE:
CB	NTS
	DESIGN BY:
	PLA
	CHECKED BY:
	JCD

**RECORD FLOOR PLAN
COMMONS BUILDING**

SECOND FLOOR PLAN

SALISBURY UNIVERSITY
FACILITIES PLANNING & CAPITAL PROJECTS
ARCHITECTURAL AND ENGINEERING SERVICES
1101 CAMDEN AVENUE
SALISBURY, MARYLAND 21801
410 - 543 - 6215